




Preliminary Process and Instrumentation Diagram

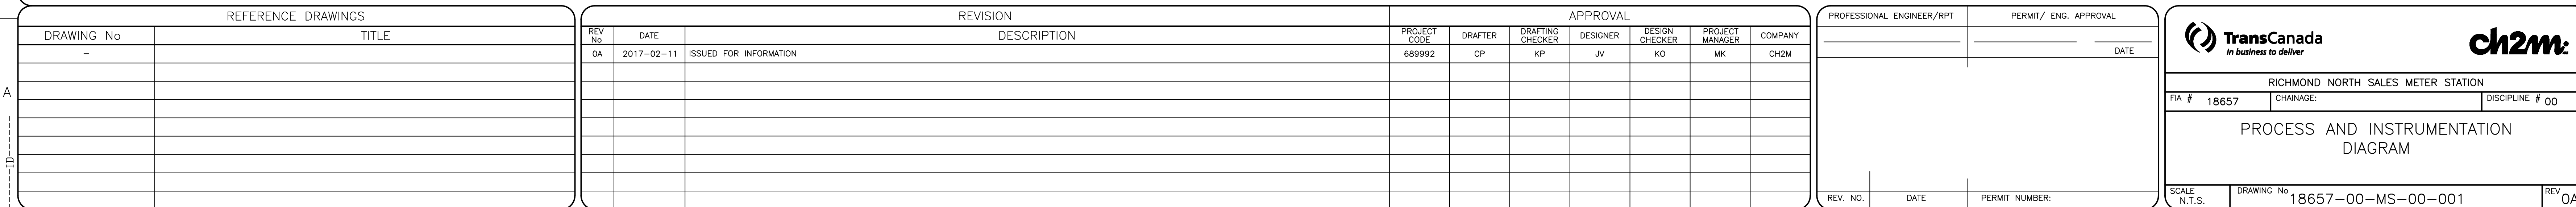

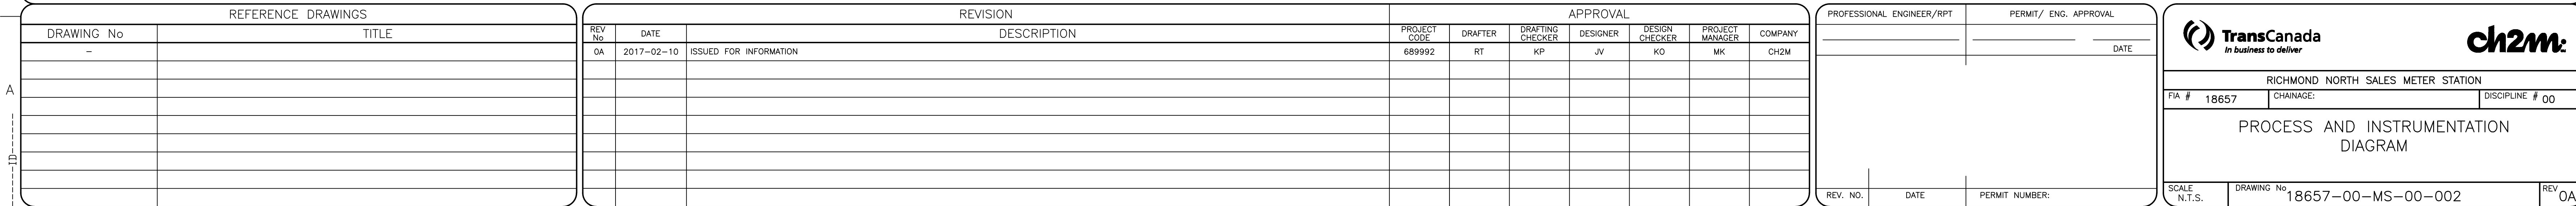

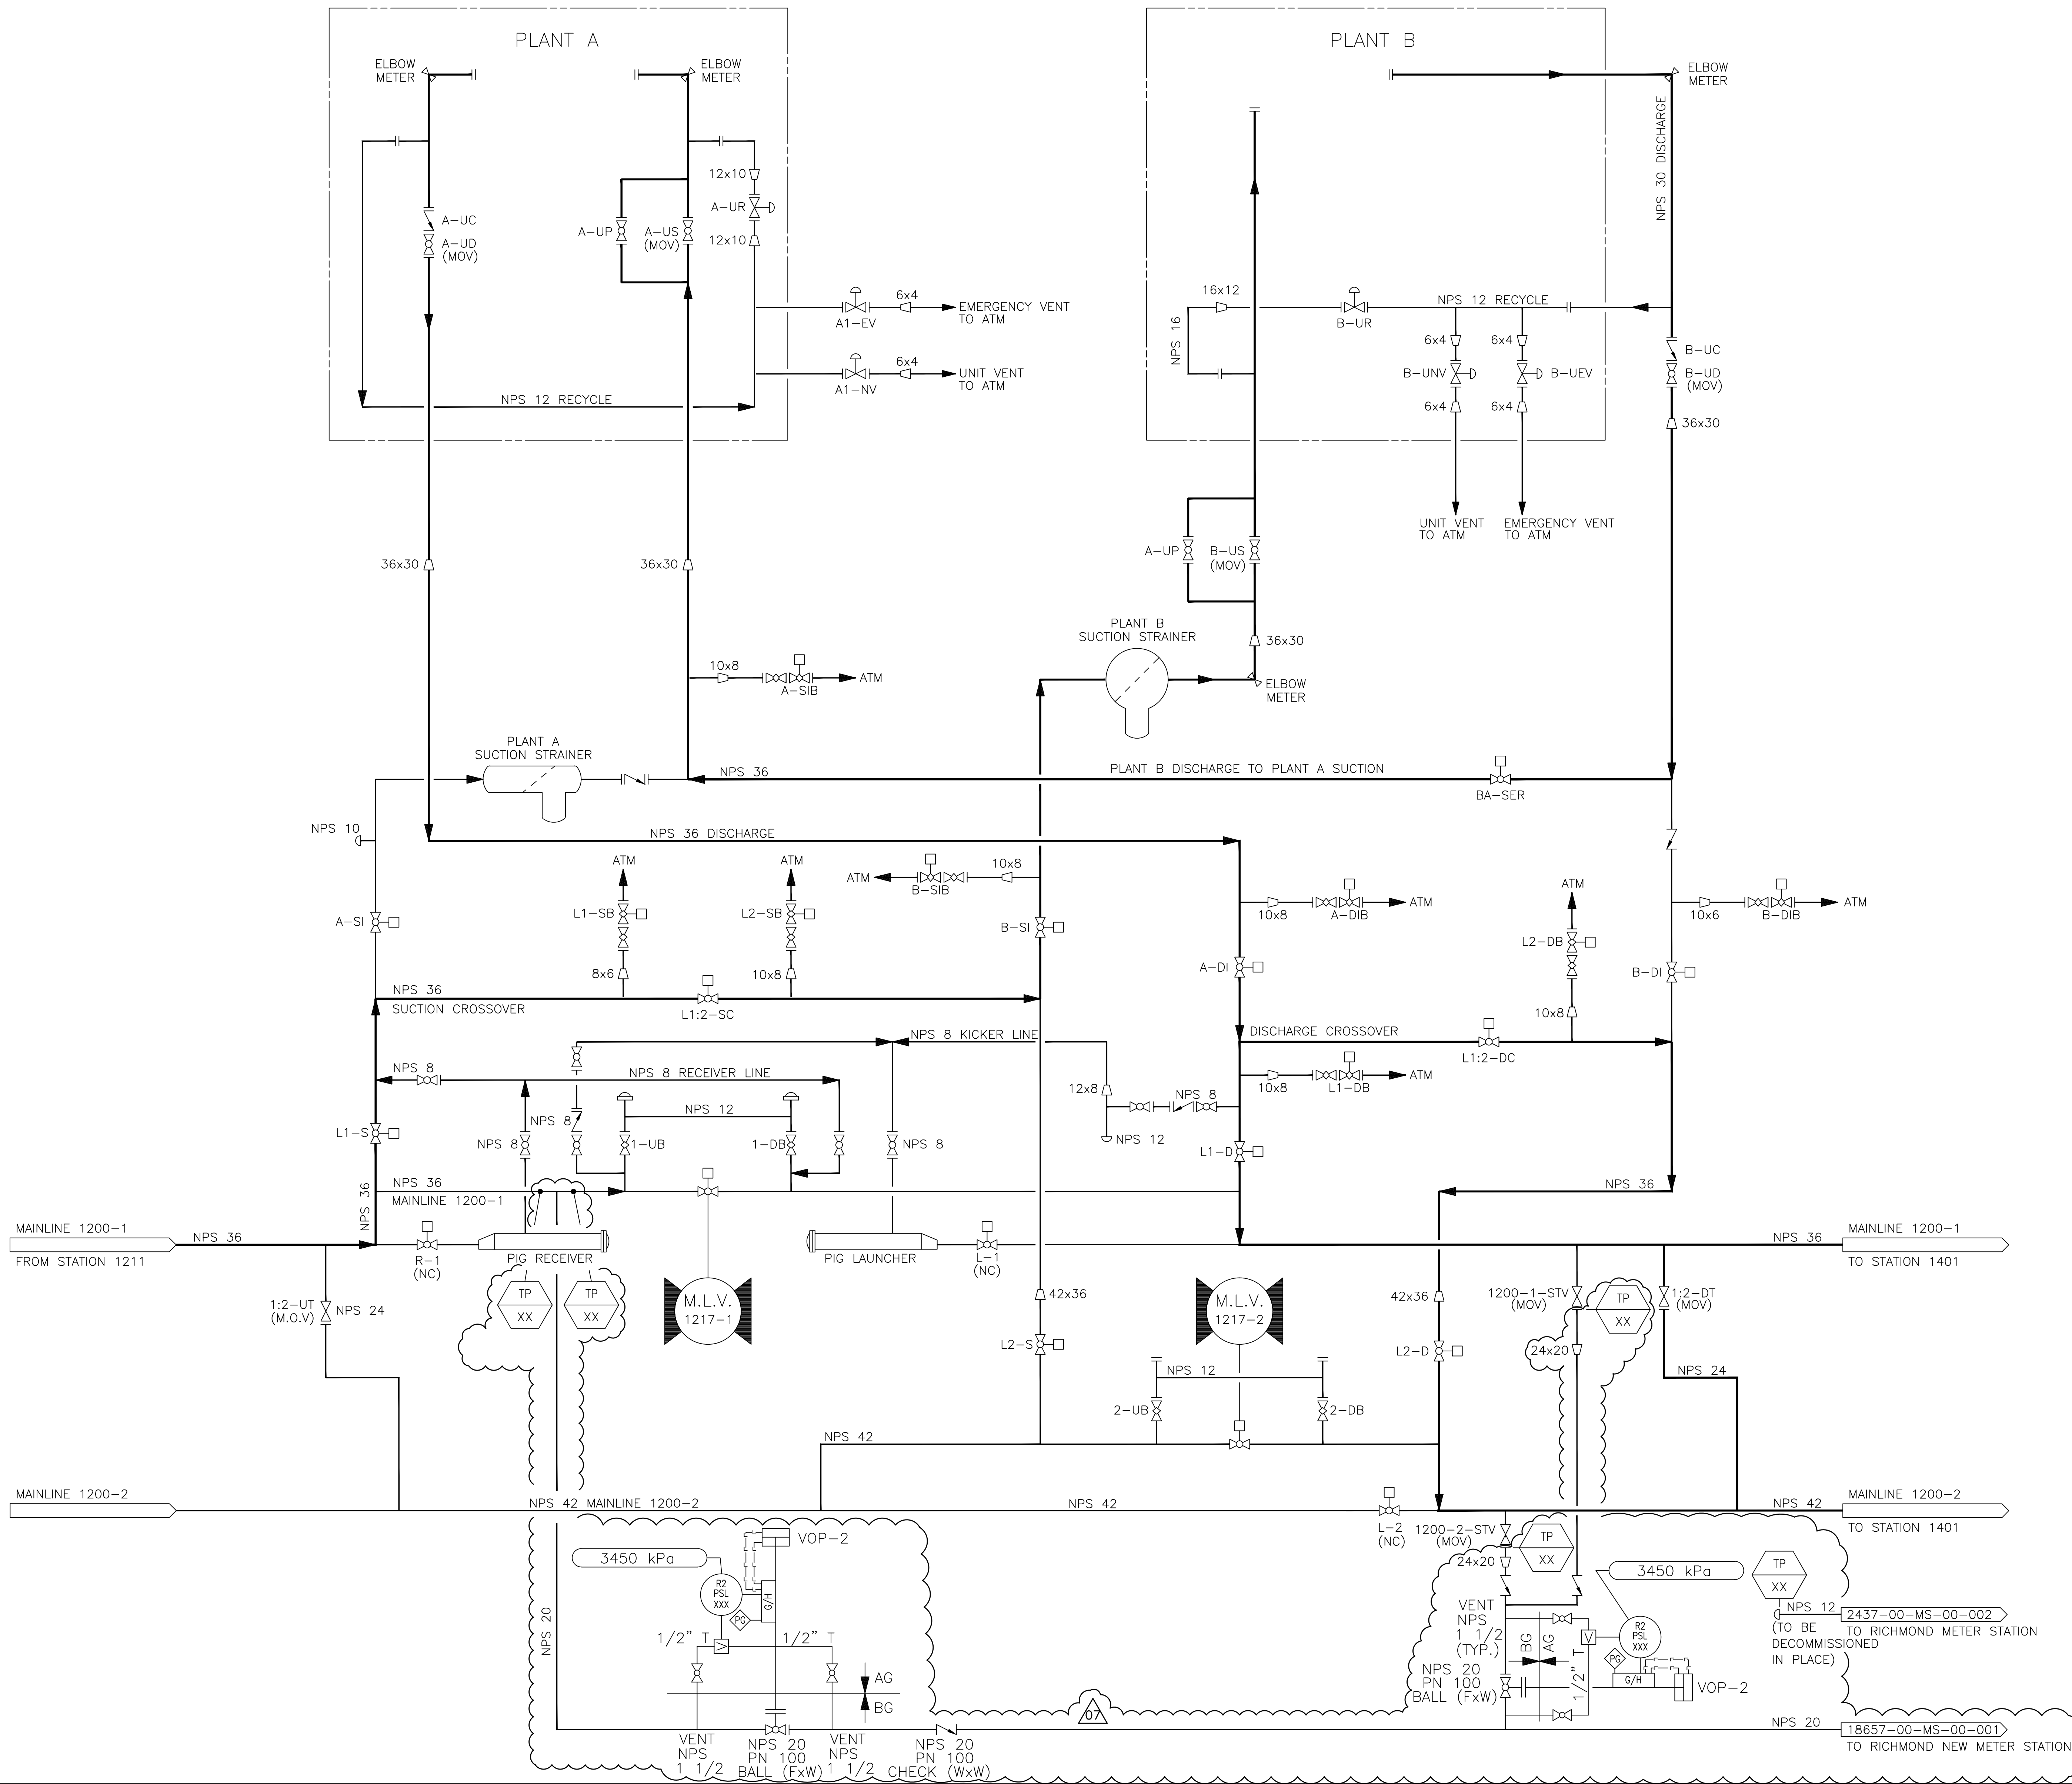




REFERENCE DRAWINGS	
NUMBER	TITLE
A1-1217ST-00-D2-02	P & ID - SYMBOL LEGEND
A1-1217ST-06-D2-01	H.P. GAS PIPING - STATION YARD - P & ID

07A	2017-02-13	689992	ISSUED FOR REVIEW	RHS	JV				CH2M
06	2015-02-20	2.226644	ISSUED FOR CONSTRUCTION	HT					STARCO
5	1999-04-05	T00762	NOVEMBER 1998 ASBUILT	IET	Jvb	COA			CALTECH
4	1997-04-05		ASBUILT AS PER FIELD MARKUP	S.K.	F.L.L.		F.L.		TCPL
3	1995-05-22		DWG. NO. SUPERSEDED FROM SK-H-227	T.A.L.					TCPL
2	1992-04-06		ADDED LINE 1200-2	T.L.	G.P.				TCPL

REV	DATE	TCPJ PROJECT NO	REVISION DESCRIPTION	REV BY	CHK BY	CO- ORD	DSGN ENG	SUPV ENG	PROJ E/M	CMPY	
<div>TransCanada <i>In business to deliver</i></div> <div></div>											
DRAWING TITLE											
HIGH PRESSURE GAS SYSTEM OPERATING SCHEMATIC											
REGIONAL MUNICIPALITY OF OTTAWA-CARLETON									ONTARIO		
LOCATION: STATION No. 1217											
DRAFTER	R.A.B.	DATE	1991-02-20	CONTRACTOR FILE/DRAWING NUMBER							
CHECKER	B.M.S.	DATE	1991-02-22	TCPJ PROJECT NUMBER T00762				DWG SCALE		N.T.S.	
COORDINATOR	E.R.J.	DATE	1991-02-22	TCPJ DRAWING NUMBER							
DESIGN ENG	Y.L.	DATE	1991-02-22	A1-1217ST-00-D2-01							07A
PROJ MGR		DATE									
ENG SUPV		DATE									
											REV

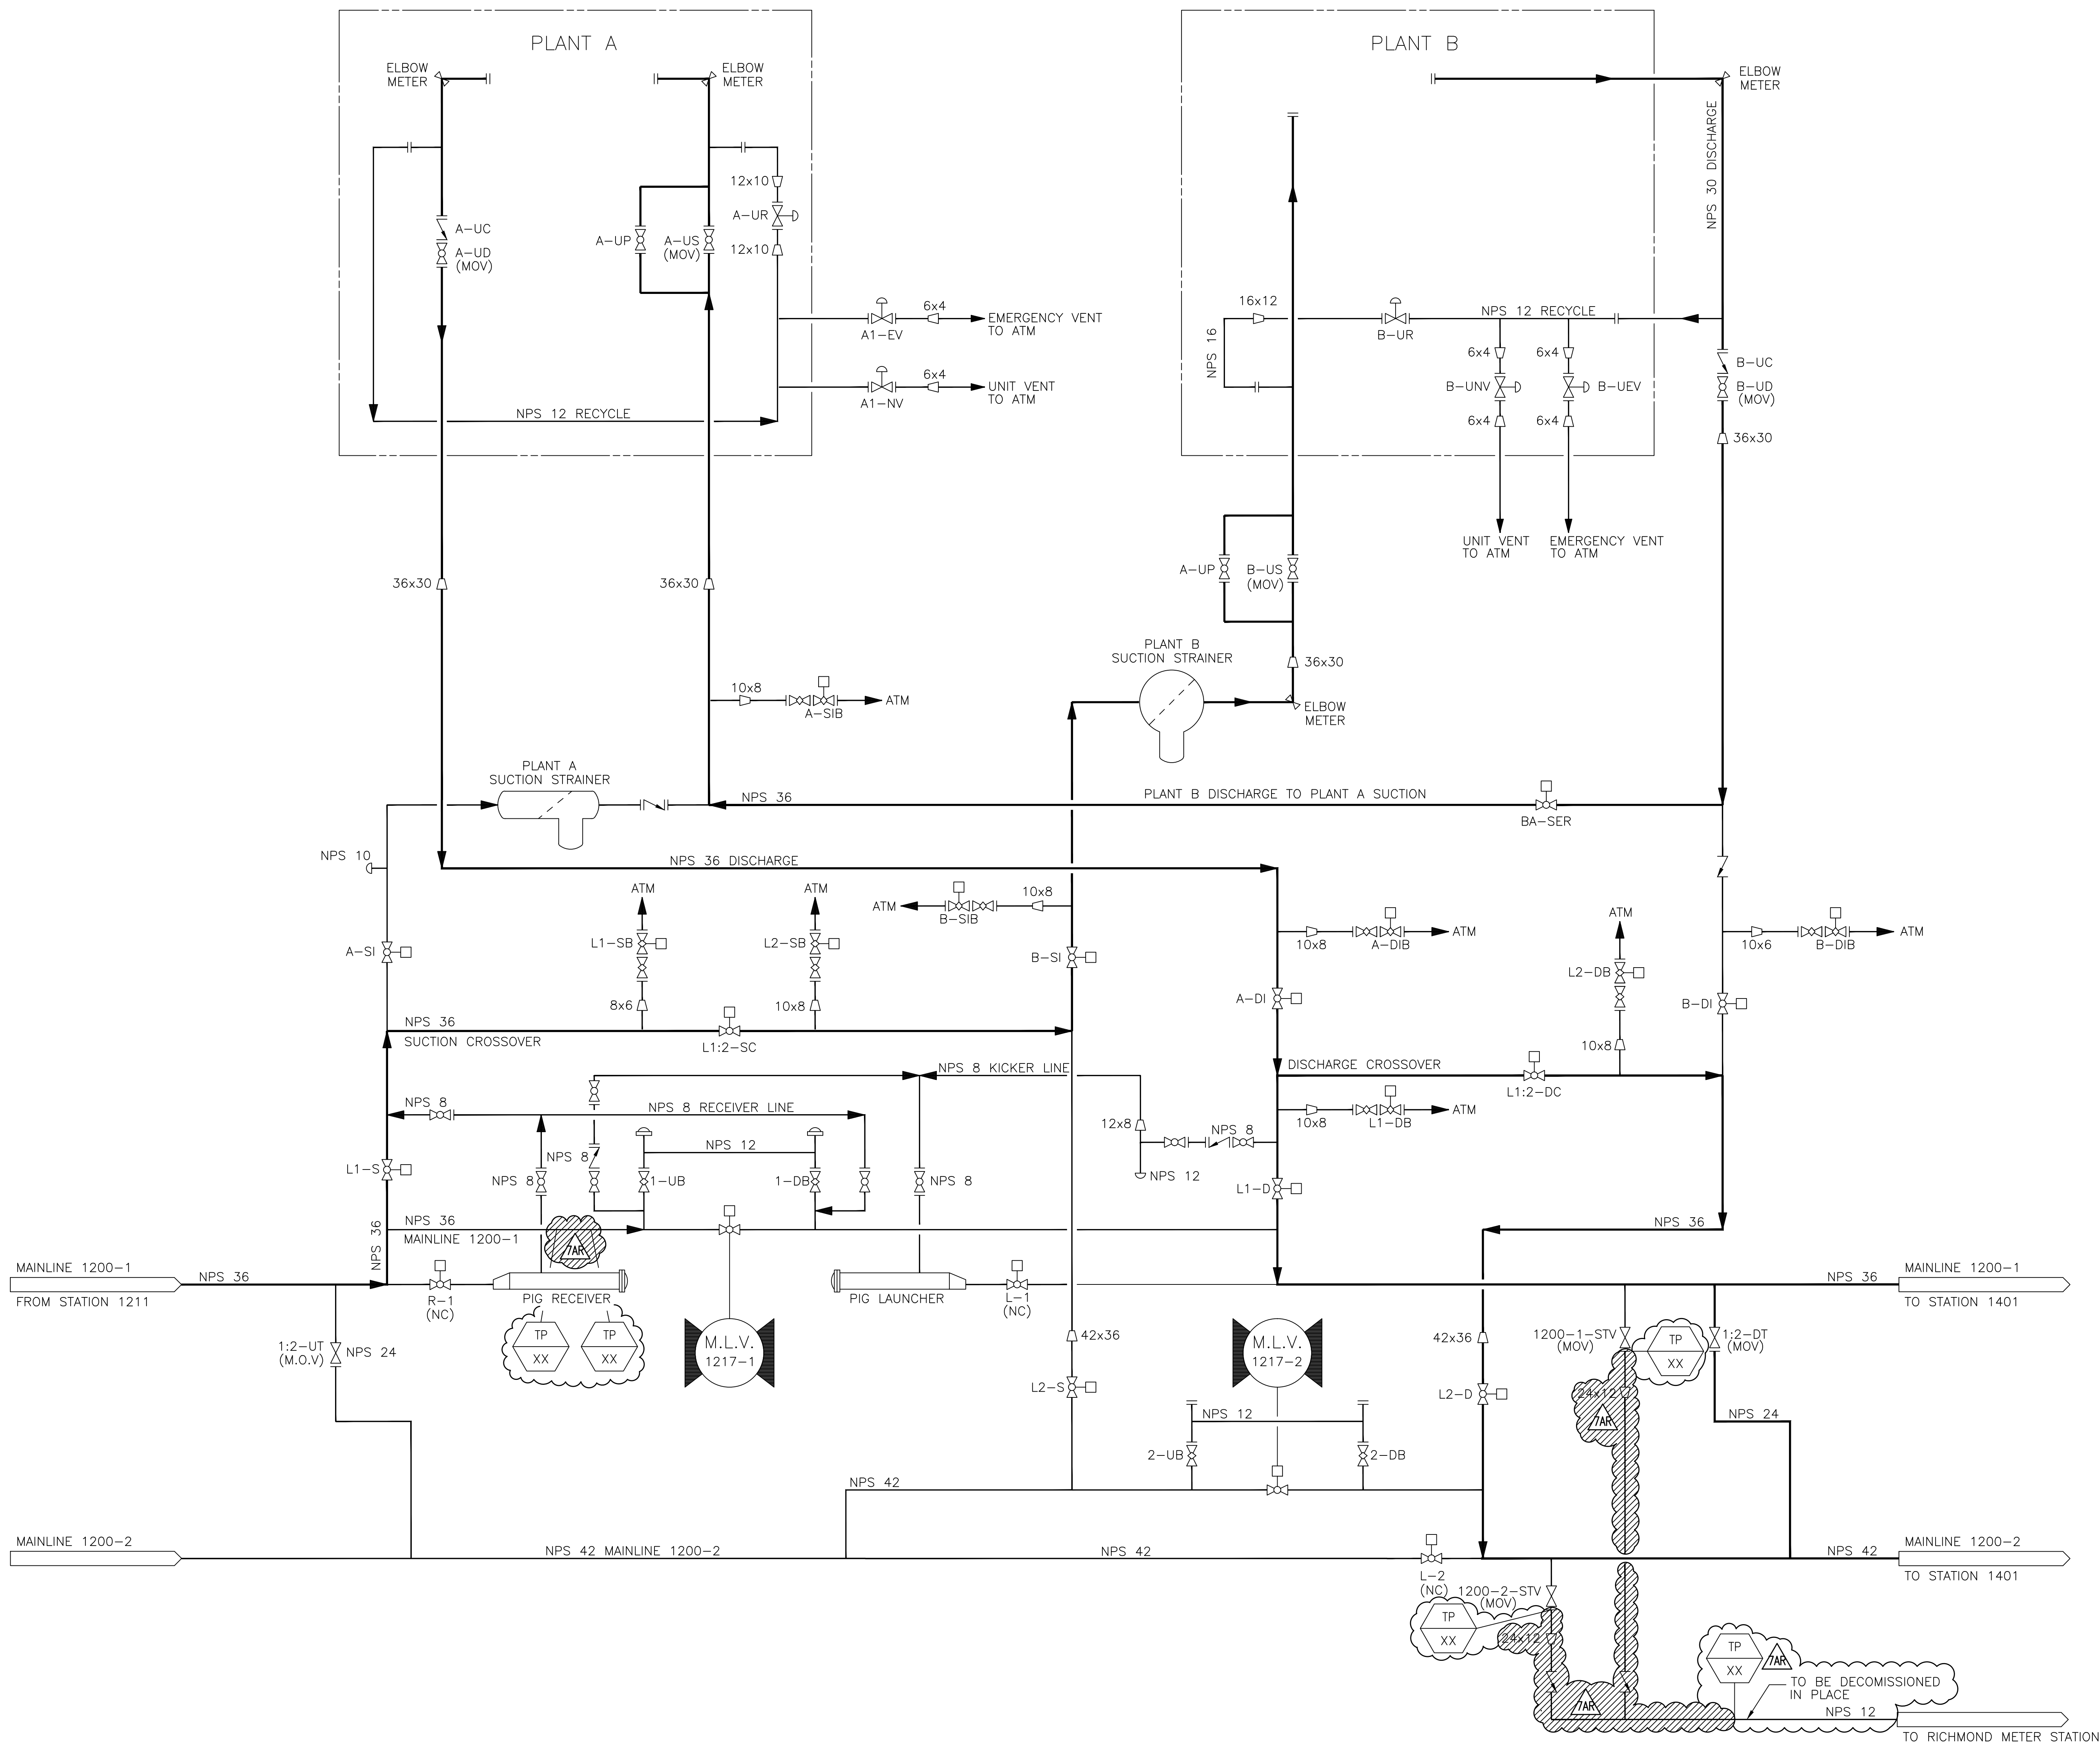

REFERENCE DRAWINGS	
NUMBER	TITLE
A1-1217ST-00-D2-02	P & ID - SYMBOL LEGEND
A1-1217ST-06-D2-01	H.P. GAS PIPING - STATION YARD - P & ID

7	2017-02-13	689992	ISSUED FOR REVIEW	R	HT	JV					CH2M
6	2015-02-20	2.226644	ISSUED FOR CONSTRUCTION	R	RS						STARCO
5	1999-04-05	T00762	NOVEMBER 1998 ASBUILT	I	ET	JvB	COA				CALTECH
4	1997-04-15		ASBUILT AS PER FIELD MARKUP	S	K	F.L.					TCPL
3	1996-05-22		DWG. NO. SUPERSSEDED FROM SK-H-22	T	A.L.						TCPL
2	1992-04-06		ADDED LINE 1200-2	T	L	G.P.					TCPL
1	1991-03-27	TCPL	ORIGINAL CONTRACT DOCUMENTS	R	EV	CH	CO	DSGN	SUPV	PROJ	CONV



ch2m:

HIGH PRESSURE GAS SYSTEM OPERATING SCHEMATIC (REMOVAL)

REGIONAL MUNICIPALITY OF OTTAWA—CARLETON ONTARIO

LOCATION: STATION No. 1217

DRAFTER	R.A.B.	DATE 1991-02-20	CONTRACTOR FILE/DRAWING NUMBER
---------	--------	-----------------	--------------------------------

CHECKER	B.M.S.	DATE	1991-02-22	TCPL PROJECT NUMBER T00762	DWG SCALE N.T.S.
DESIGNER	F.B.I.	DATE	1991-02-22		

COORDINATOR	E.R.J.	DATE	1991-02-22	TCPL DRAWING NUMBER
DESIGN ENG	Y.L.	DATE	1991-02-22	

PROJ MGR	DATE	A1-1217ST-00-D2-01	7AR
----------	------	--------------------	-----

ENG SUPV	DATE		REV
----------	------	--	-----